


VERTICAL GRANITE CURB (MOD.) (2)
GRANITE POSTS


STA.	LOCATION	DESCRIPTION
18+791.4	RT	GRANITE POST #4
18+790.1	RT	GRANITE POST #3
18+785.9	RT	GRANITE POST #2
18+768.5	RT	GRANITE POST #1

MATCH TO LANDSCAPE & LIGHTING PLAN 3

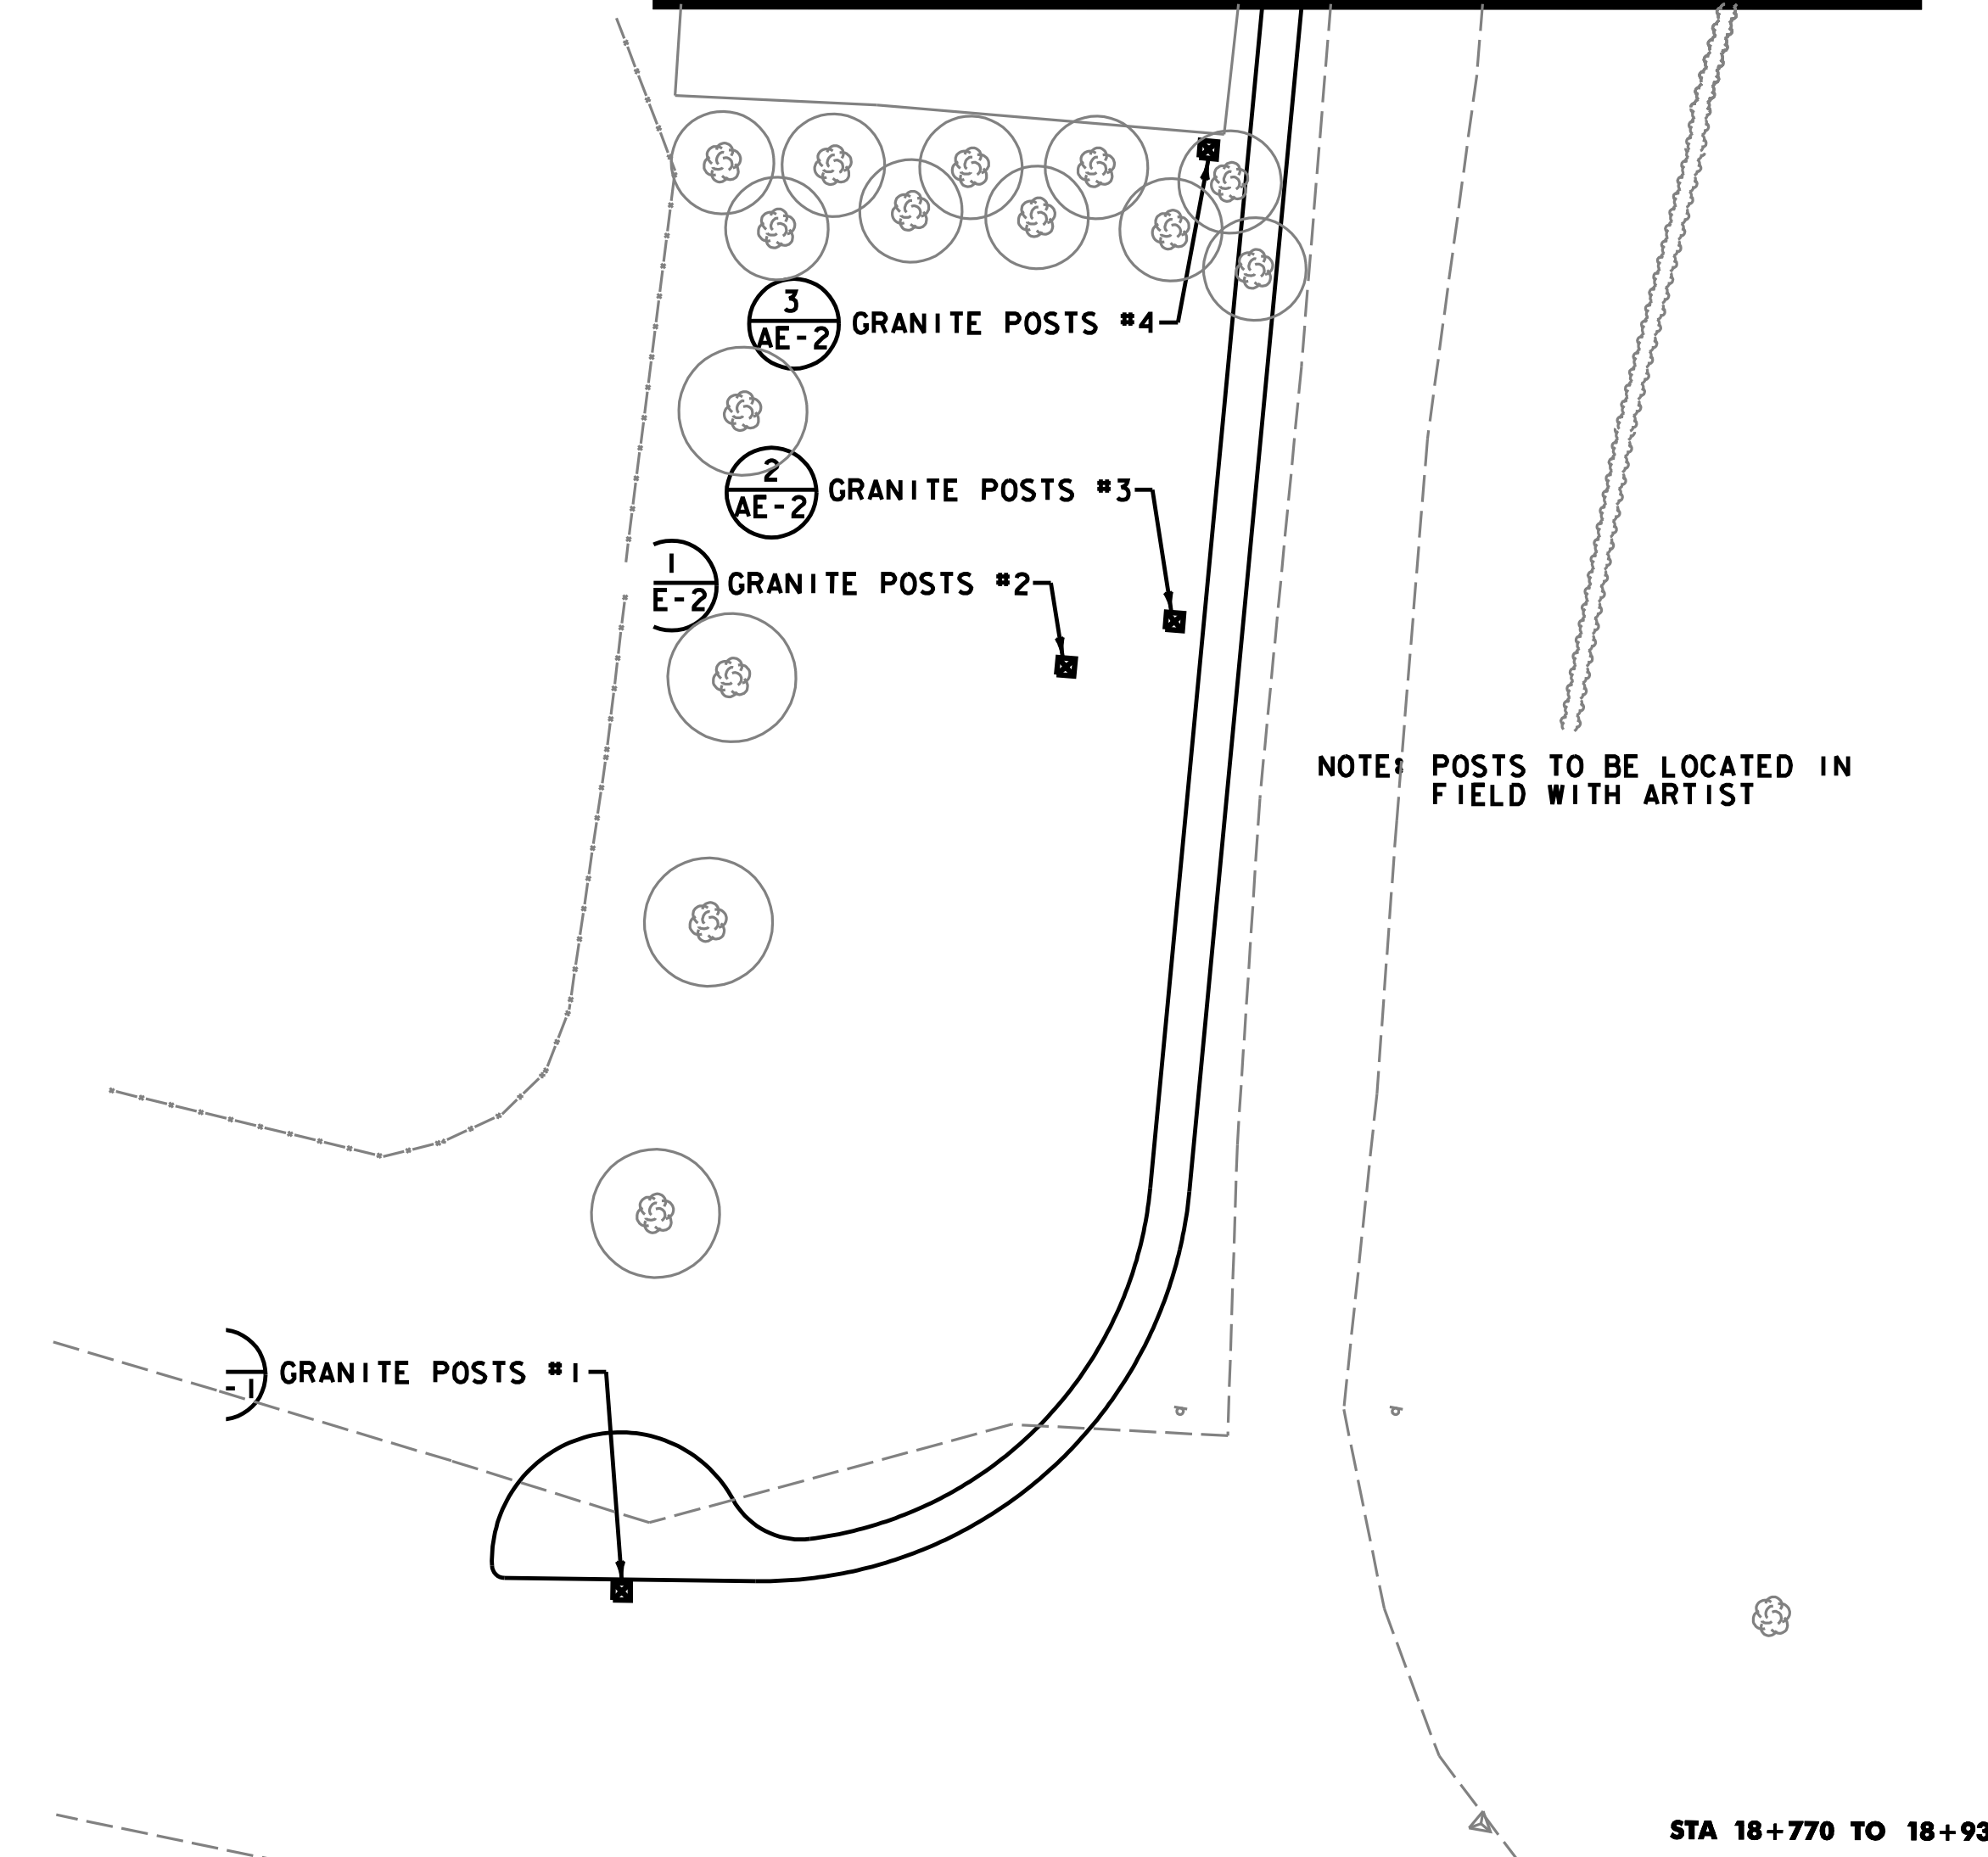

LANDSCAPE AND LIGHTING LEGEND

	PROPOSED TREES
	EXISTING TREES
	LIGHTING LOCATIONS (ARROW SHOWS DISTRIBUTION DIRECTION)
	BENCH LOCATIONS
	GRANITE POST LOCATIONS
	HANDHOLE
	ROUTE 2 LIGHTING METER PEDESTAL SEE DETAIL ON DRAWING.....
	DANVILLE GREEN METER PEDESTAL SEE DETAIL ON DRAWING.....

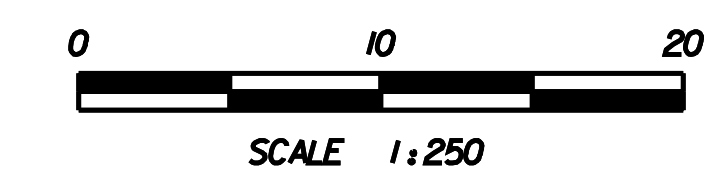

PROJECT NAME: DANVILLE	PLOT DATE: 6/7/2007
PROJECT NUMBER: F EGC 028-3(32)	DRAWN BY: PZA
FILE NAME: z010nvl.dgn	CHECKED BY: GAS
PROJECT LEADER: GAS	SHEET OF
DESIGNED BY: JJS	
LANDSCAPE & LIGHTING PLAN 11	